


LEGEND


GFCI - GROUND FAULT CIRCUIT INTERRUPTER
 WP - WEATHERPROOF

Prepared by:
CHEVRON ENERGY SOLUTIONS COMPANY
 A Division of Chevron U.S.A., Inc.
 OVERLAND PARK, KS OFFICE
 12960 FOSTER DRIVE, SUITE 400
 TEL 913 748 8800
 FAX 913 748 8734

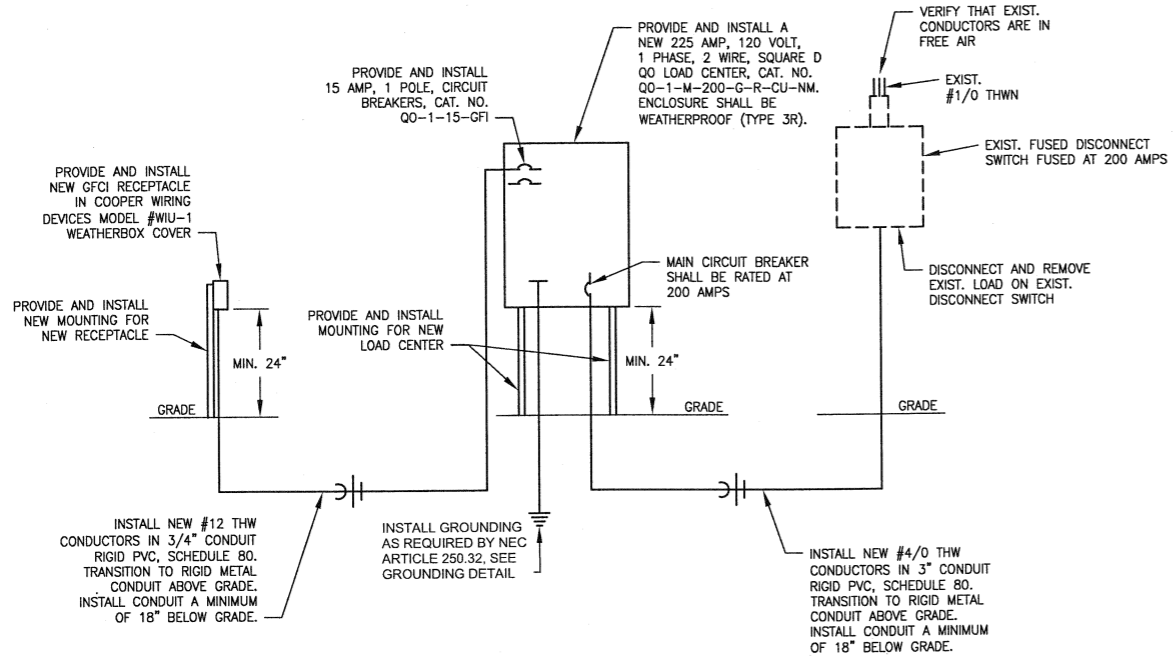


ELECTRICAL DIAGRAM
 NOT TO SCALE

NOTE:
 COORDINATE NUMBER OF OUTLETS, CIRCUITS AND CIRCUIT BREAKERS WITH OWNER.

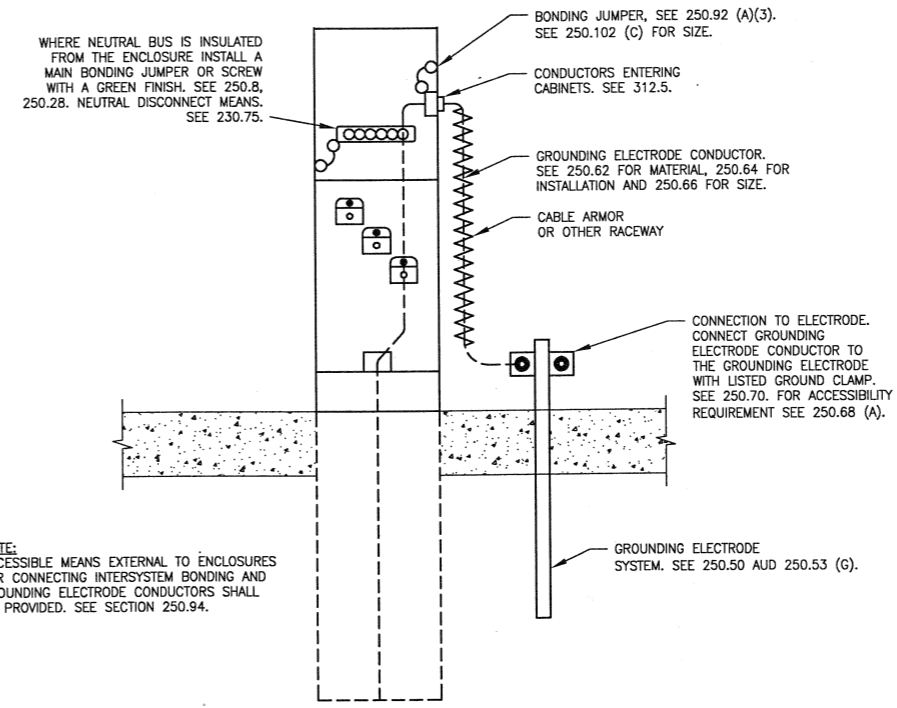

GROUNDING DIAGRAM
 NOT TO SCALE

NOTE:
 ACCESSIBLE MEANS EXTERNAL TO ENCLOSURES FOR CONNECTING INTERSYSTEM BONDING AND GROUNDING ELECTRODE CONDUCTORS SHALL BE PROVIDED. SEE SECTION 250.94.

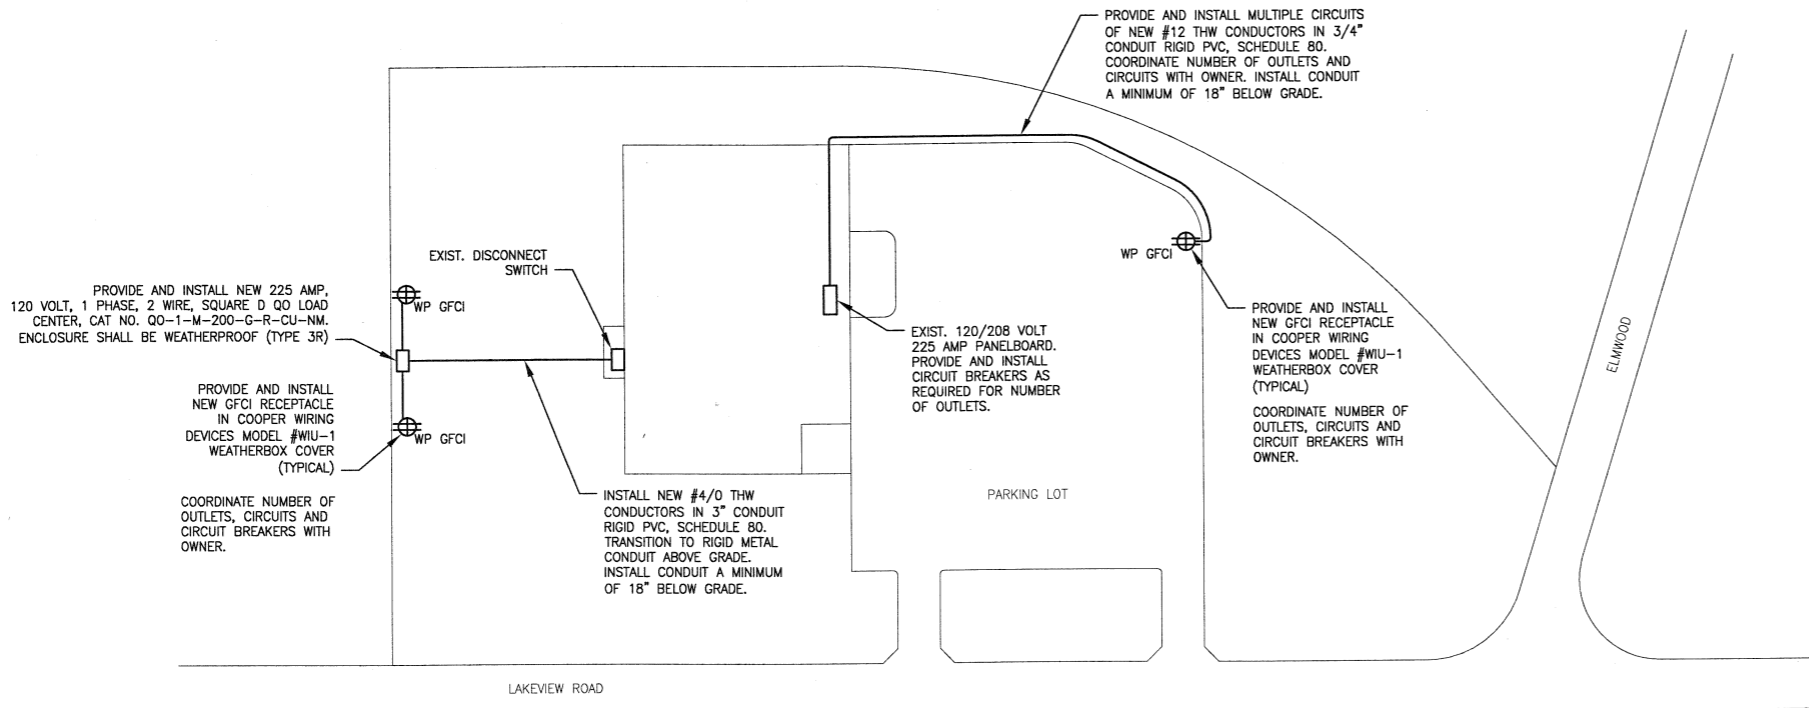

SITE PLAN
 SCALE: 1"=100'



REV	DATE	BY	DESCRIPTION
01	04-01-10	RLK	ISSUED TO OWNER

MEXICO PUBLIC SCHOOLS
MEXICO, MO
 NEW BUS BARN
 BUS HEATER ELECTRICAL INSTALLATION

SCALE	AS NOTED
PROJECT NO.	2063
DESIGNED BY	RLK
DRAWN BY	JDB
CHECKED BY	RLK
DATE	04-01-10
LAYOUT TAB	11x17-NXTB
XREFS	
XREFS (CONT)	
XREFS (CONT)	
FILE NAME	2063-ELEC-BUS-NEW