


EXISTING EQUIPMENT LEGEND

- ① SILVERWARE
- ② SERVING LINE WITH 8 HOT/COLD WELLS (EA)
- ③ COLD/SALAD
- ④ MILK
- ⑤ CHECK OUT
- ⑥ TABLE & STAND
- ⑦ ICE MACHINE
- ⑧ REFRIGERATOR
- ⑨ OVENS
- ⑩ STOVE
- ⑪ STEAM KETTLE
- ⑫ PIZZA OVEN
- ⑬ SILVERWARE
- ⑭ SILVERWARE
- ⑮ SILVERWARE

NEW EQUIPMENT LEGEND

- Ⓐ TRAY DISPENSER
- Ⓑ SERVING COUNTER
- Ⓒ TILT SKILLET
- Ⓓ SHELVING UNITS
- Ⓔ WALK-IN COOLER
- Ⓕ WALK-IN FREEZER

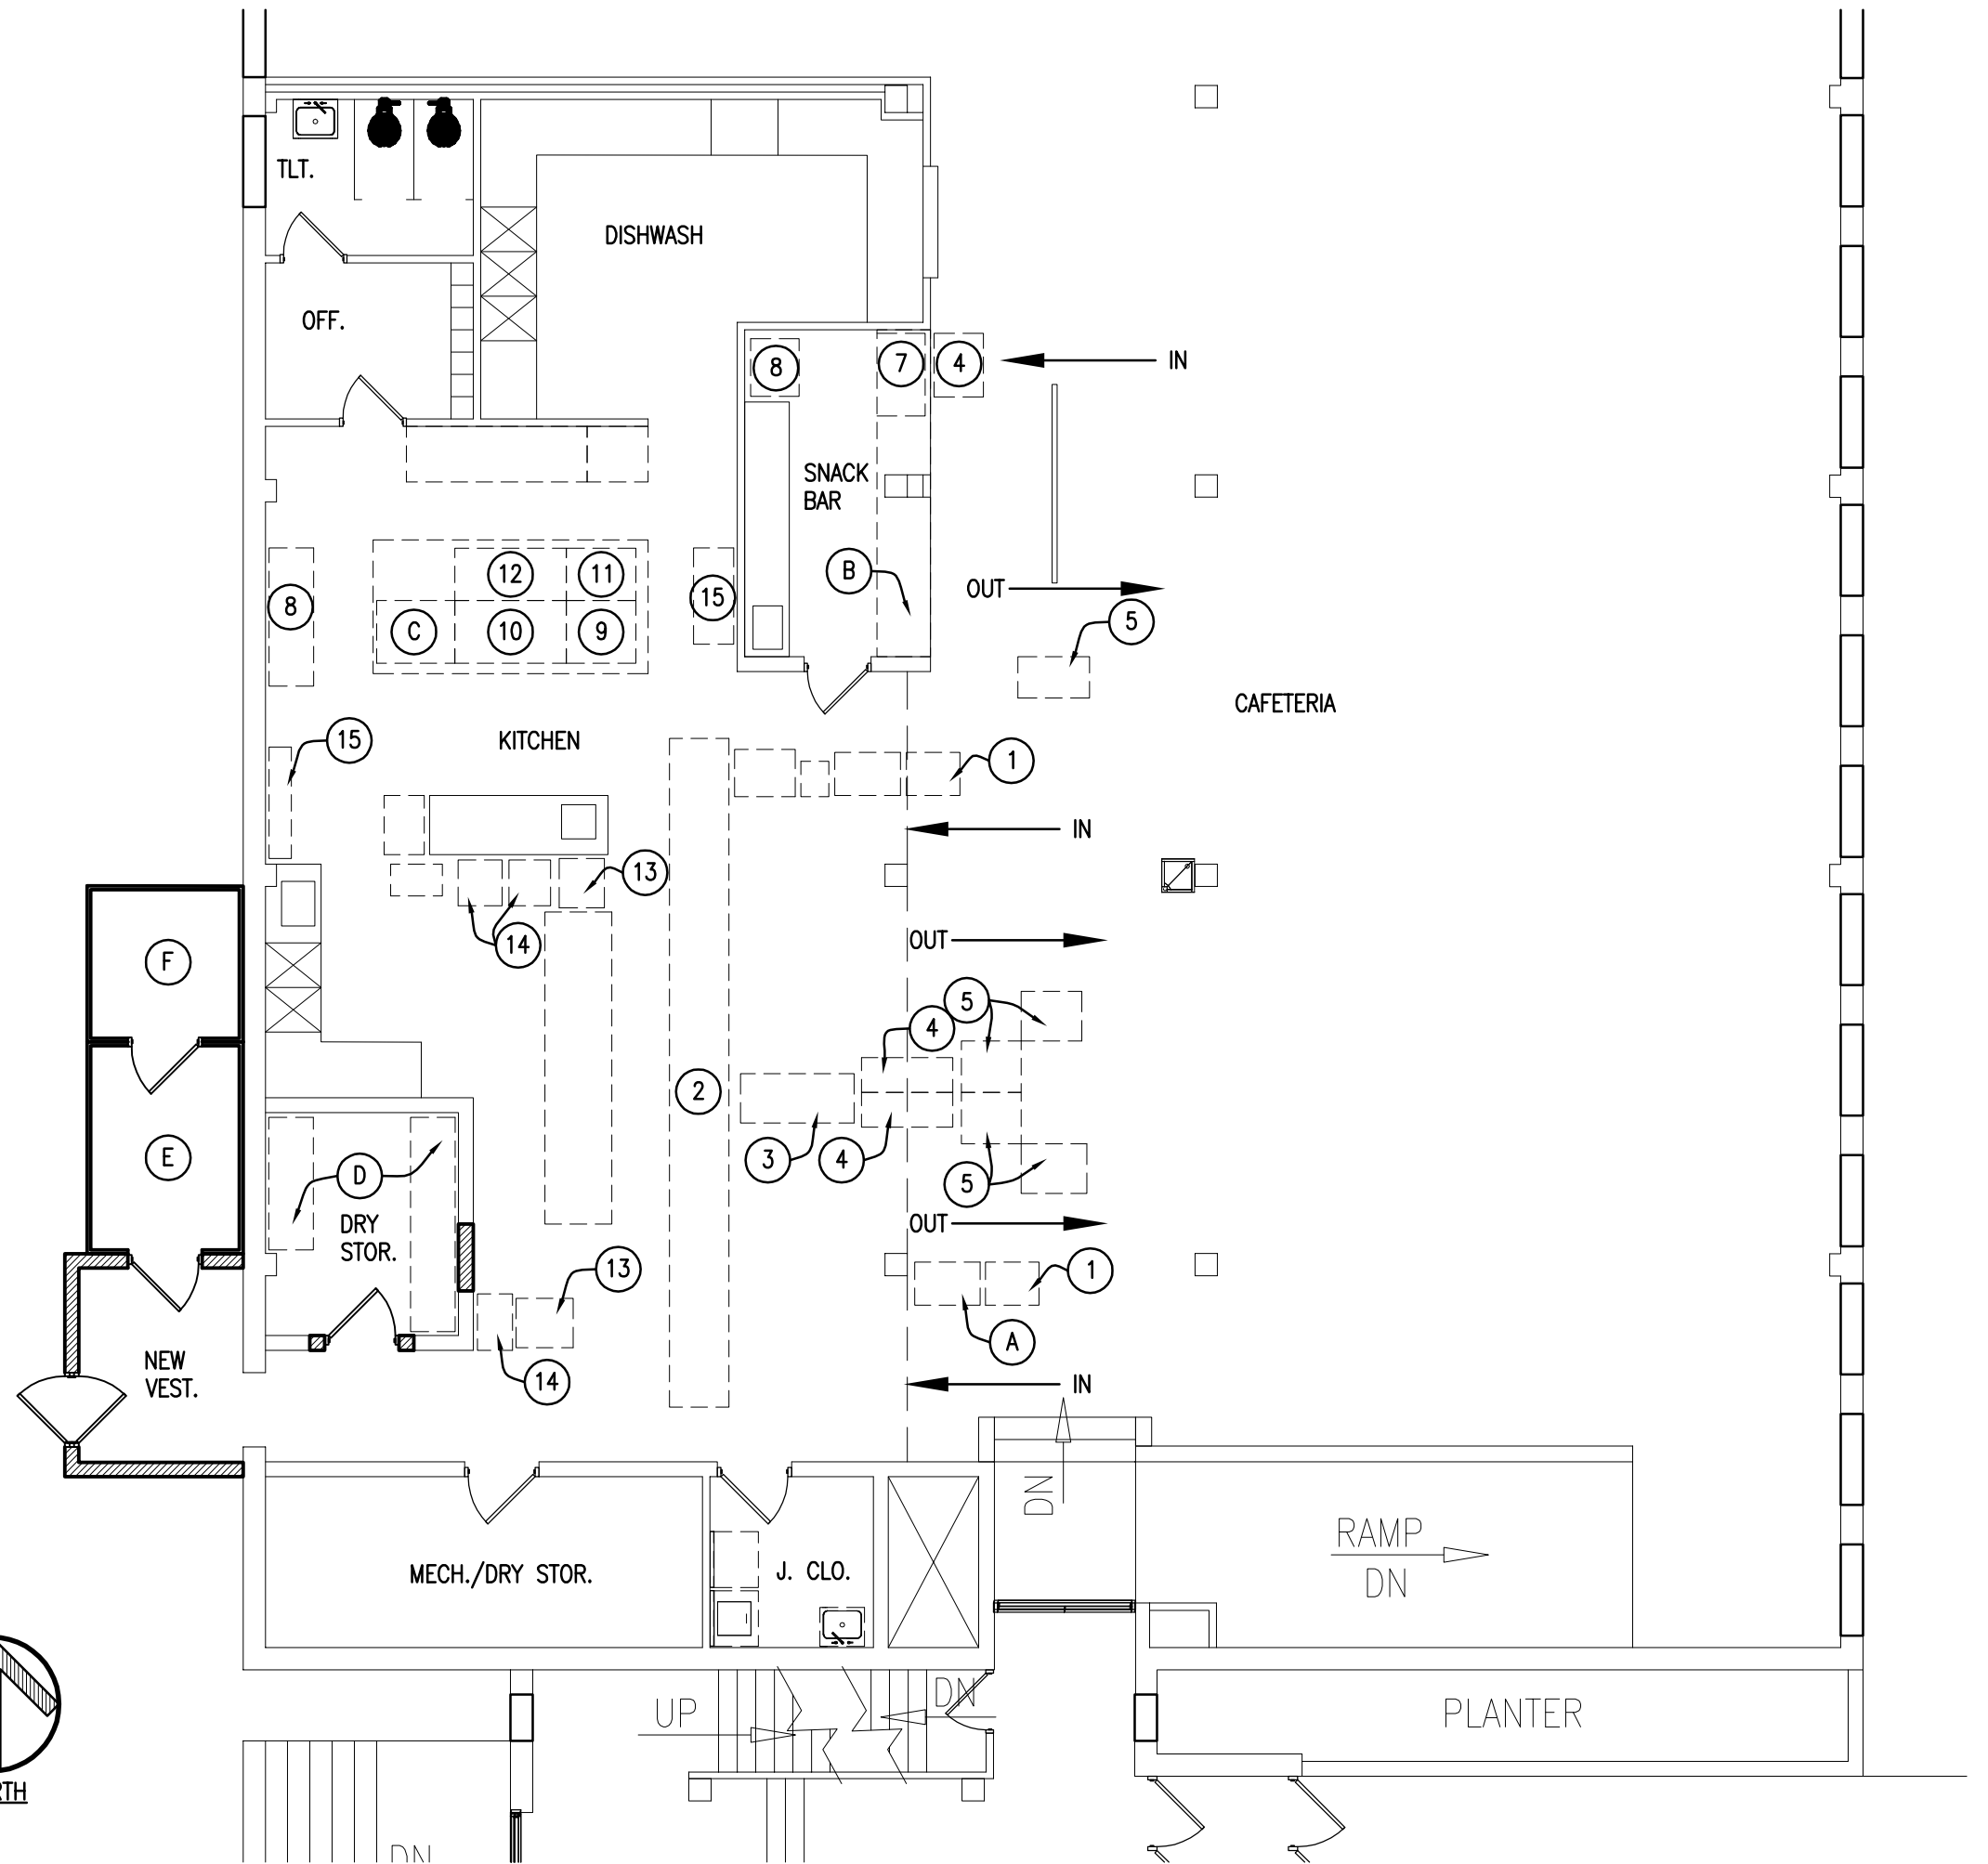

FLOOR PLAN
SCALE: 1/8" = 1'-0"

